


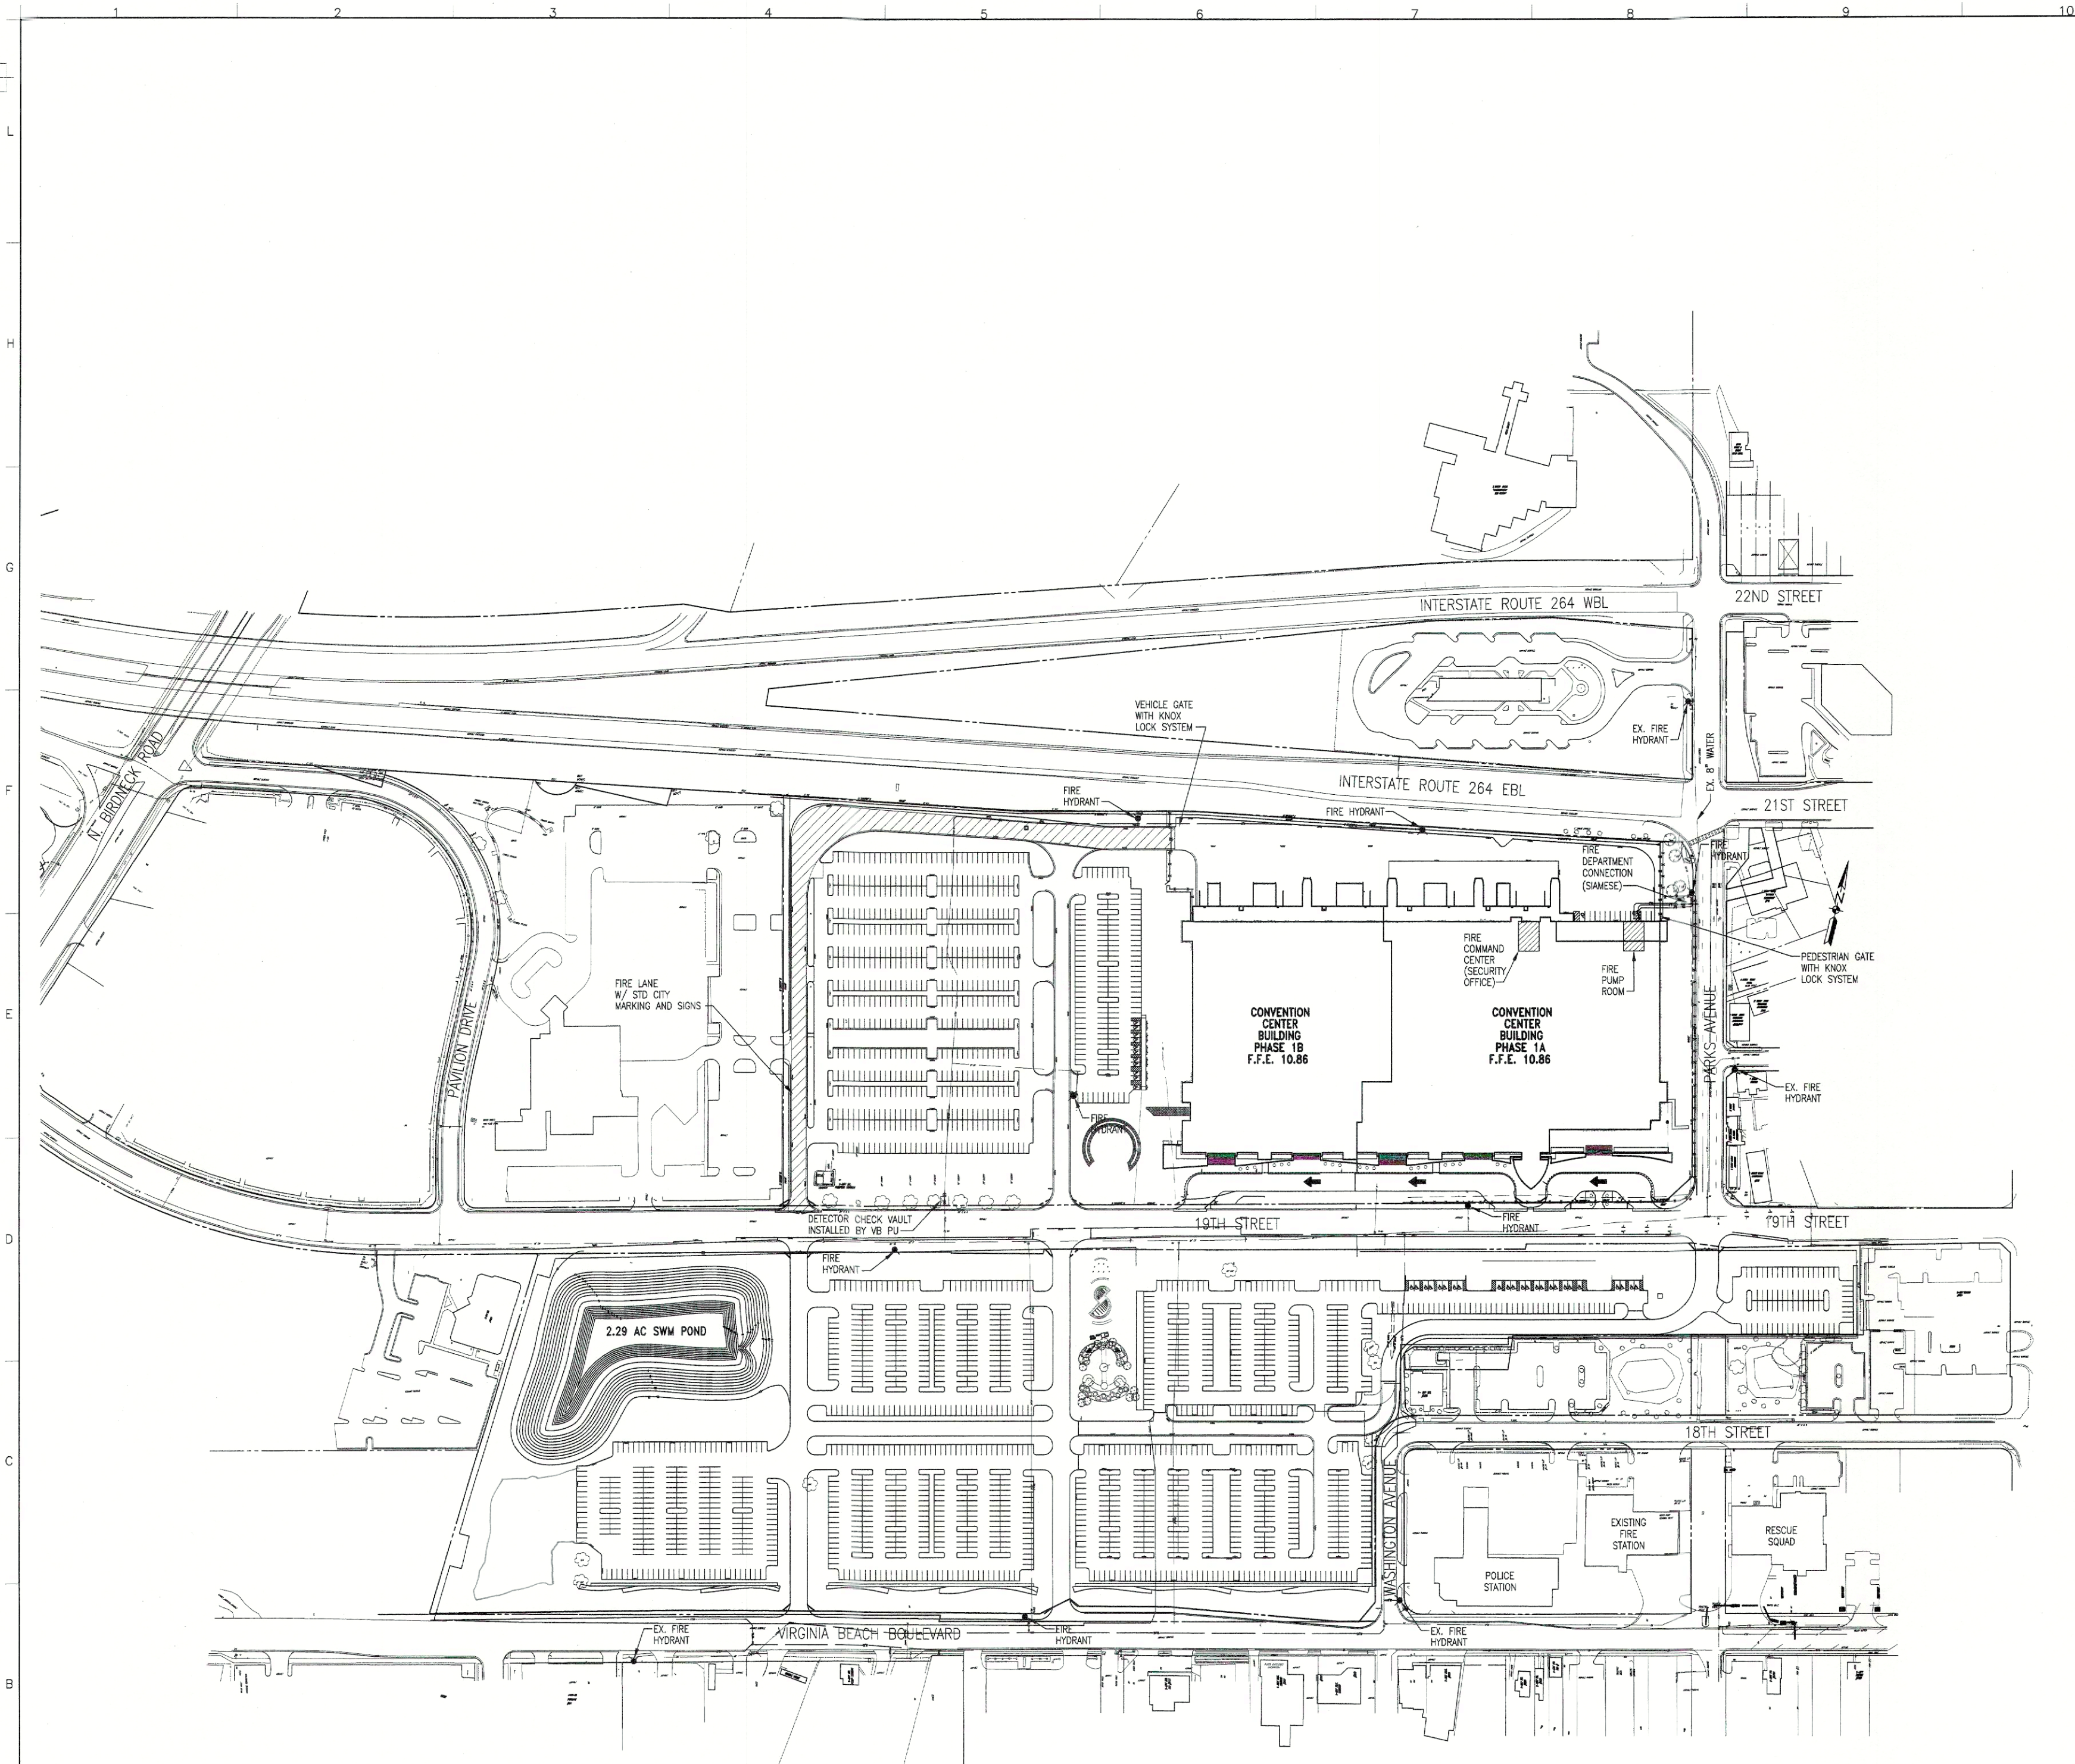

- NOTES
1. THIS PLAN HIGHLIGHTS ITEMS PERTINENT TO THE OVERALL FIRE PROTECTION SYSTEM FOR THE CONVENTION CENTER. SEE SPECIFIC PLAN SHEETS FOR DETAILED LOCATIONS AND LAYOUT OF ITEMS HIGHLIGHTED ON THIS PLAN.
 2. SEE SHEETS C-106A, C-107A AND C-122A FOR PEDESTRIAN FIRE EXIT ROUTES ALONG NORTH AND EAST SIDES OF EXISTING PAVILION BUILDING DURING PHASE 1A CONSTRUCTION.


Virginia Beach Convention Center
City of Virginia Beach
Department of Public Works
Municipal Center - Building 2
2405 Courthouse Drive,
Virginia Beach 23456-9031

Architect / Engineer:
SOM
Skidmore, Owings & Merrill LLP
224 South Michigan Avenue
Suite 1000
Chicago, Illinois 60604

Consultant: Engineering:
CLARK•NEXSEN
Architecture & Engineering
6160 Kempsville Circle
Suite 200A
Norfolk, Virginia 23502

Seal & Signature

10 7 NOV 03 BULLETIN NO. 1 - ISSUED FOR FINAL CONSTRUCTION
09 12 AUG 03 ADDENDUM NO. 14 - ISSUED FOR CONSTRUCTION AND DISC PERMIT
08 30 MAY 03 ADD. NO. 10 - ISSUED FOR FINAL OMP
07 5 MAY 03 ISSUED FOR BUILDING PERMIT
06 2 MAY 03 ADDENDUM NO. 8 - ISSUED FOR OMP
05 18 APR 03 ISSUED FOR VA BEACH DISC PERMIT
04 16 MAR 03 ADDENDUM NO. 6 - ISSUED FOR REVISION TO SITE DEMOLITION, DRAINAGE LAYOUT AND UTILITIES PLAN
03 26 MAR 03 ISSUED FOR VA BEACH DISC PERMIT
02 17 FEB 03 ISSUED FOR VIRGINIA BEACH DISC PERMIT
01 03 FEB 03 ISSUED FOR SITE BID PACKAGE

FIRE PROTECTION SITE CONTEXT PLAN

GRAPHIC SCALE
1"=100' 0 100' 200' 400'

Project No.: 201199
Date: Feb 03, 03
Scale: 1"=100'

Sheet No.: **C-004**

H:\PA\1575\Construction Documents\2004\11/19/2003 3:17pm.dwg




Virginia Beach Convention Center
City of Virginia Beach
Department of Public Works
Municipal Center - Building 2
2405 Courthouse Drive,
Virginia Beach 23456-9031


Architect / Engineer:
SOM
Skidmore, Owings & Merrill LLP
224 South Michigan Avenue
Suite 1000
Chicago, Illinois 60604

Consultant Engineering:
CLARK•NEXSEN
Architecture & Engineering
6160 Kampsville Circle
Suite 200A
Norfolk, Virginia 23502

Consultant:

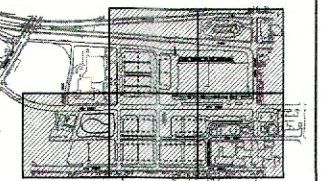

Seal & Signature

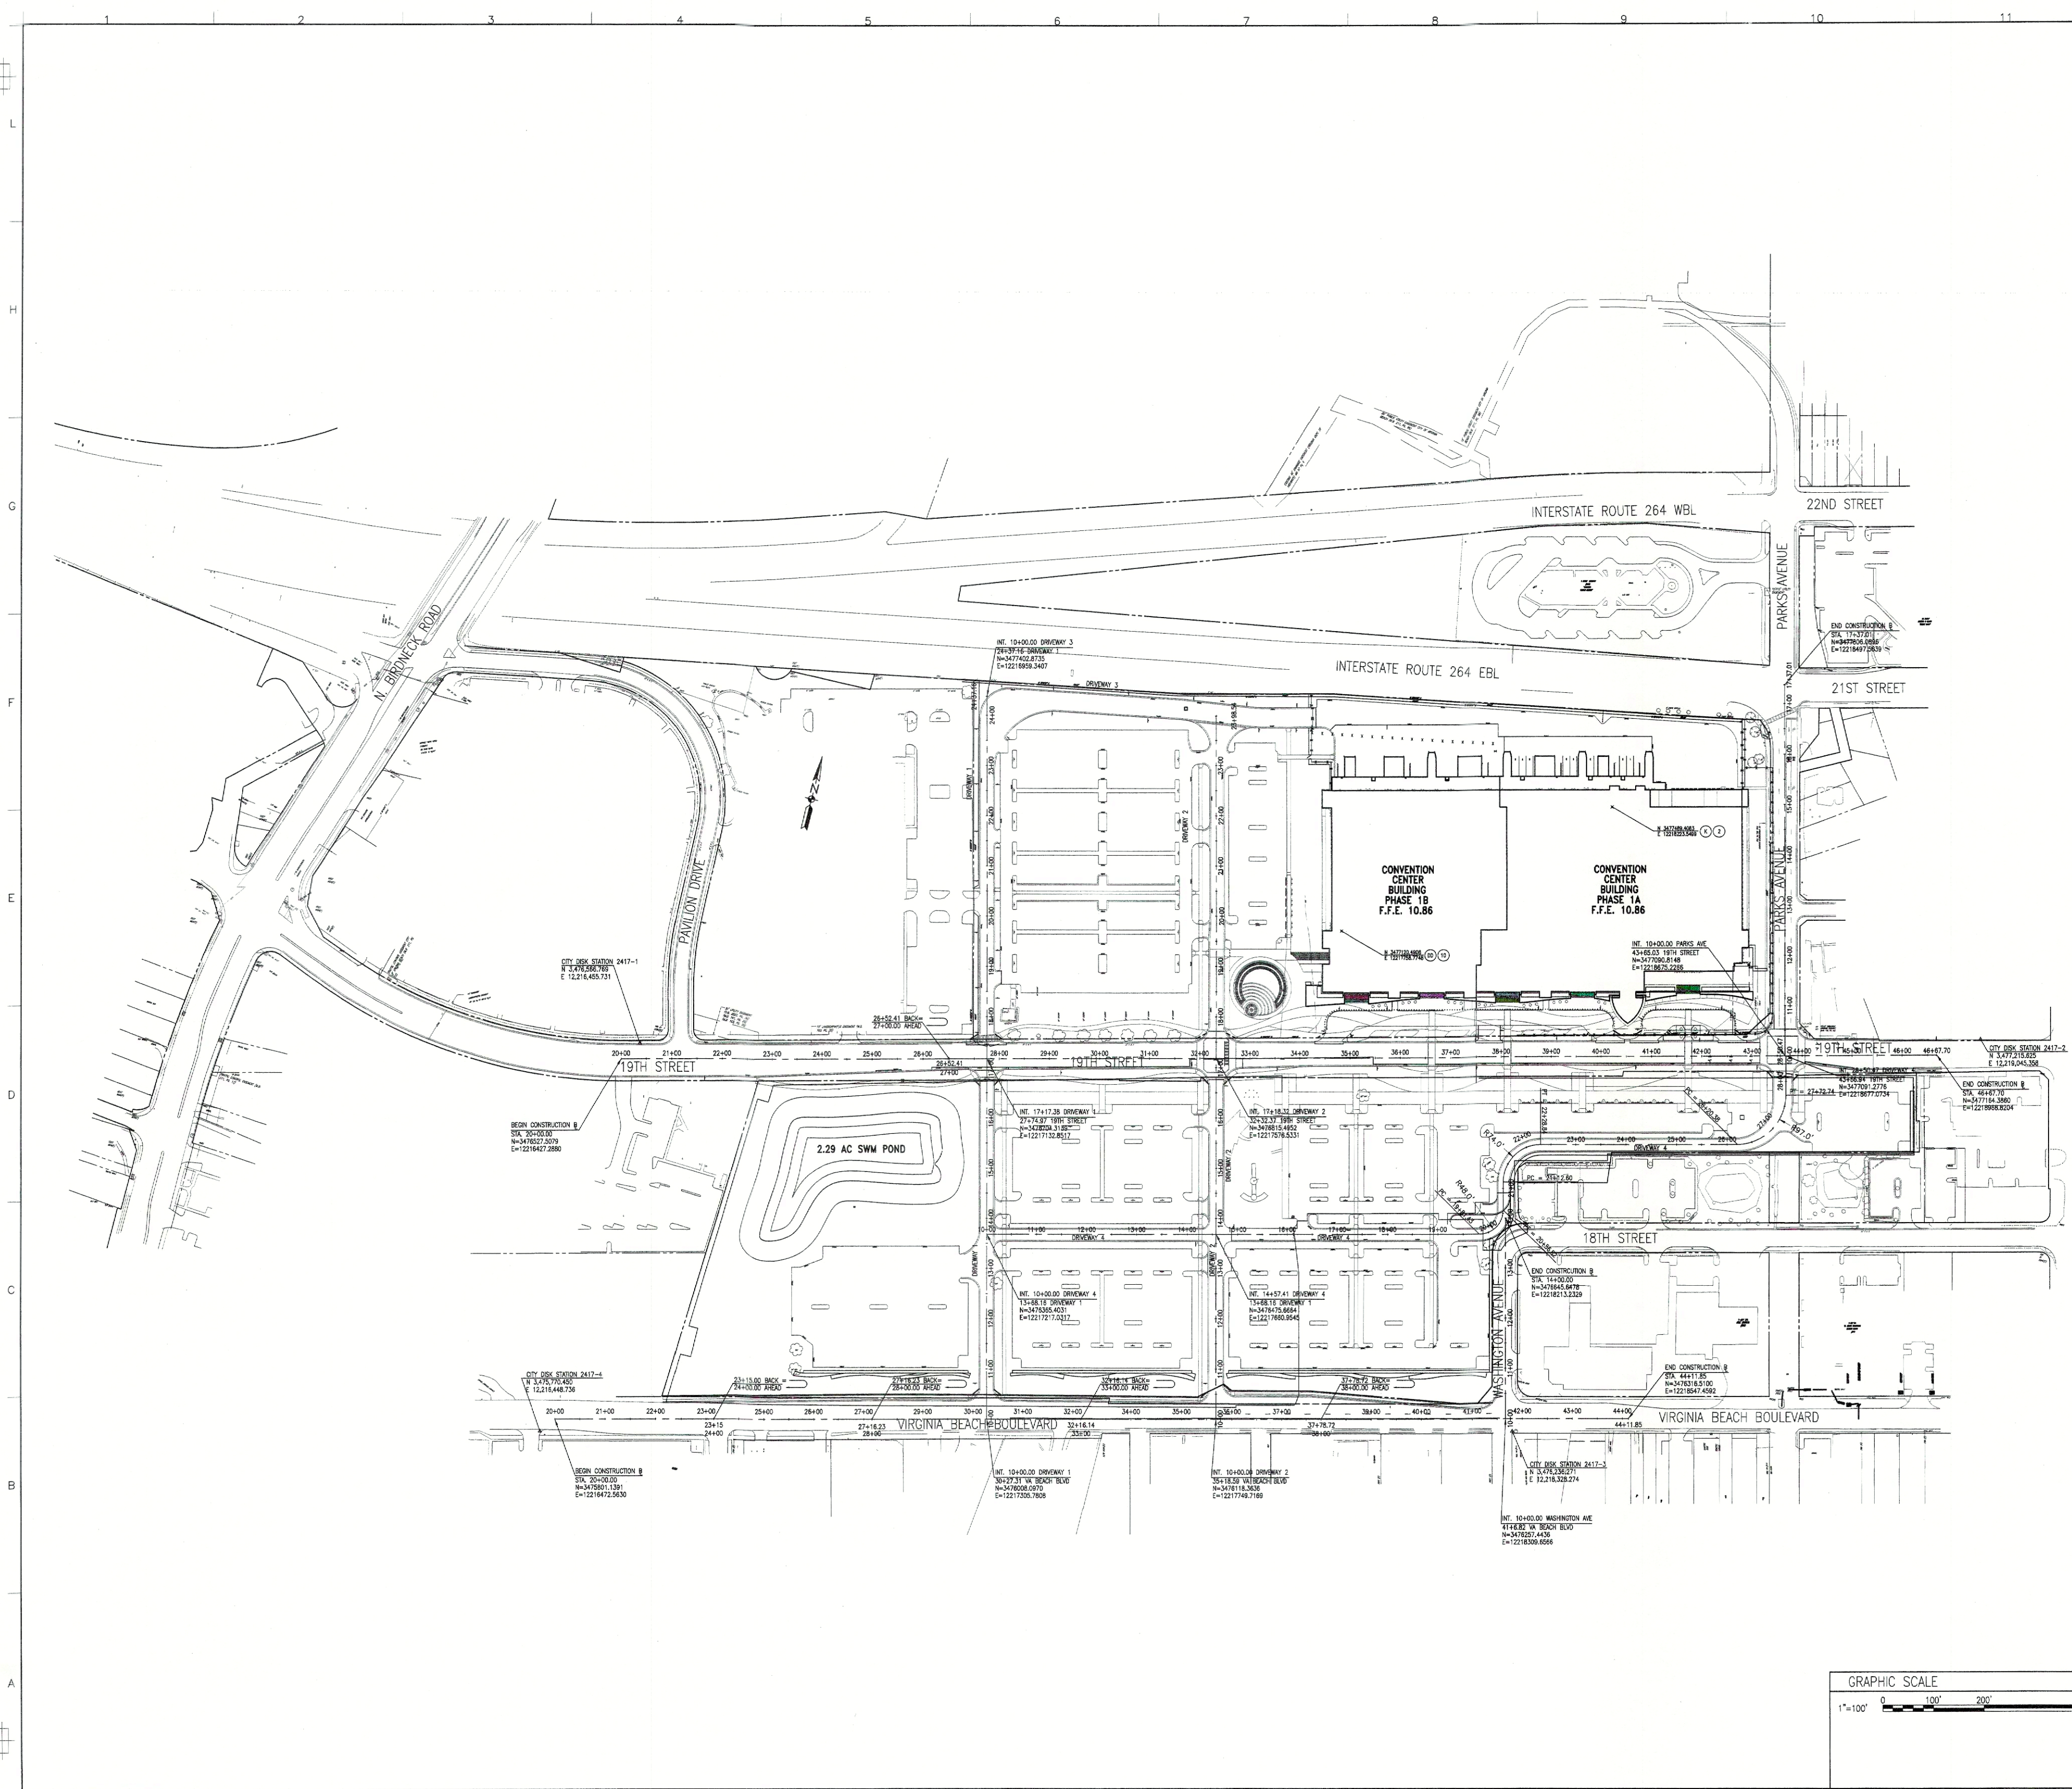



10.7 NOV. 03	BULLETIN NO. 1 - ISSUED FOR FINAL CONSTRUCTION
09.12 AUG. 03	ADDENDUM NO. 14 - ISSUE FOR CONSTRUCTION AND DSC PERMIT
08.30 MAY. 03	ADD. NO. 10 - ISSUED FOR FINAL GMP
07.15 MAY. 03	ISSUED FOR BUILDING PERMIT
06.12 MAY. 03	ADDENDUM NO. 8 - ISSUED FOR GMP
05.18 APR. 03	ISSUED FOR VA BEACH DSC PERMIT
04.26 MAR. 03	ADDENDUM NO. 6 - ISSUED FOR REVISION TO SITE DEMOLITION, DRAINAGE, LAYOUT AND UTILITIES PLAN
03.26 MAR. 03	ISSUED FOR VA BEACH DSC PERMIT
02.17 FEB. 03	ISSUED FOR VIRGINIA BEACH DSC PERMIT
01.03 FEB. 03	ISSUED FOR SITE BID PACKAGE

Sheet Name:

CONSTRUCTION BASELINES

 Project No.: 001159
Date: Feb. 03, 03
Scale: 1"=100'
Sheet No.: C-005



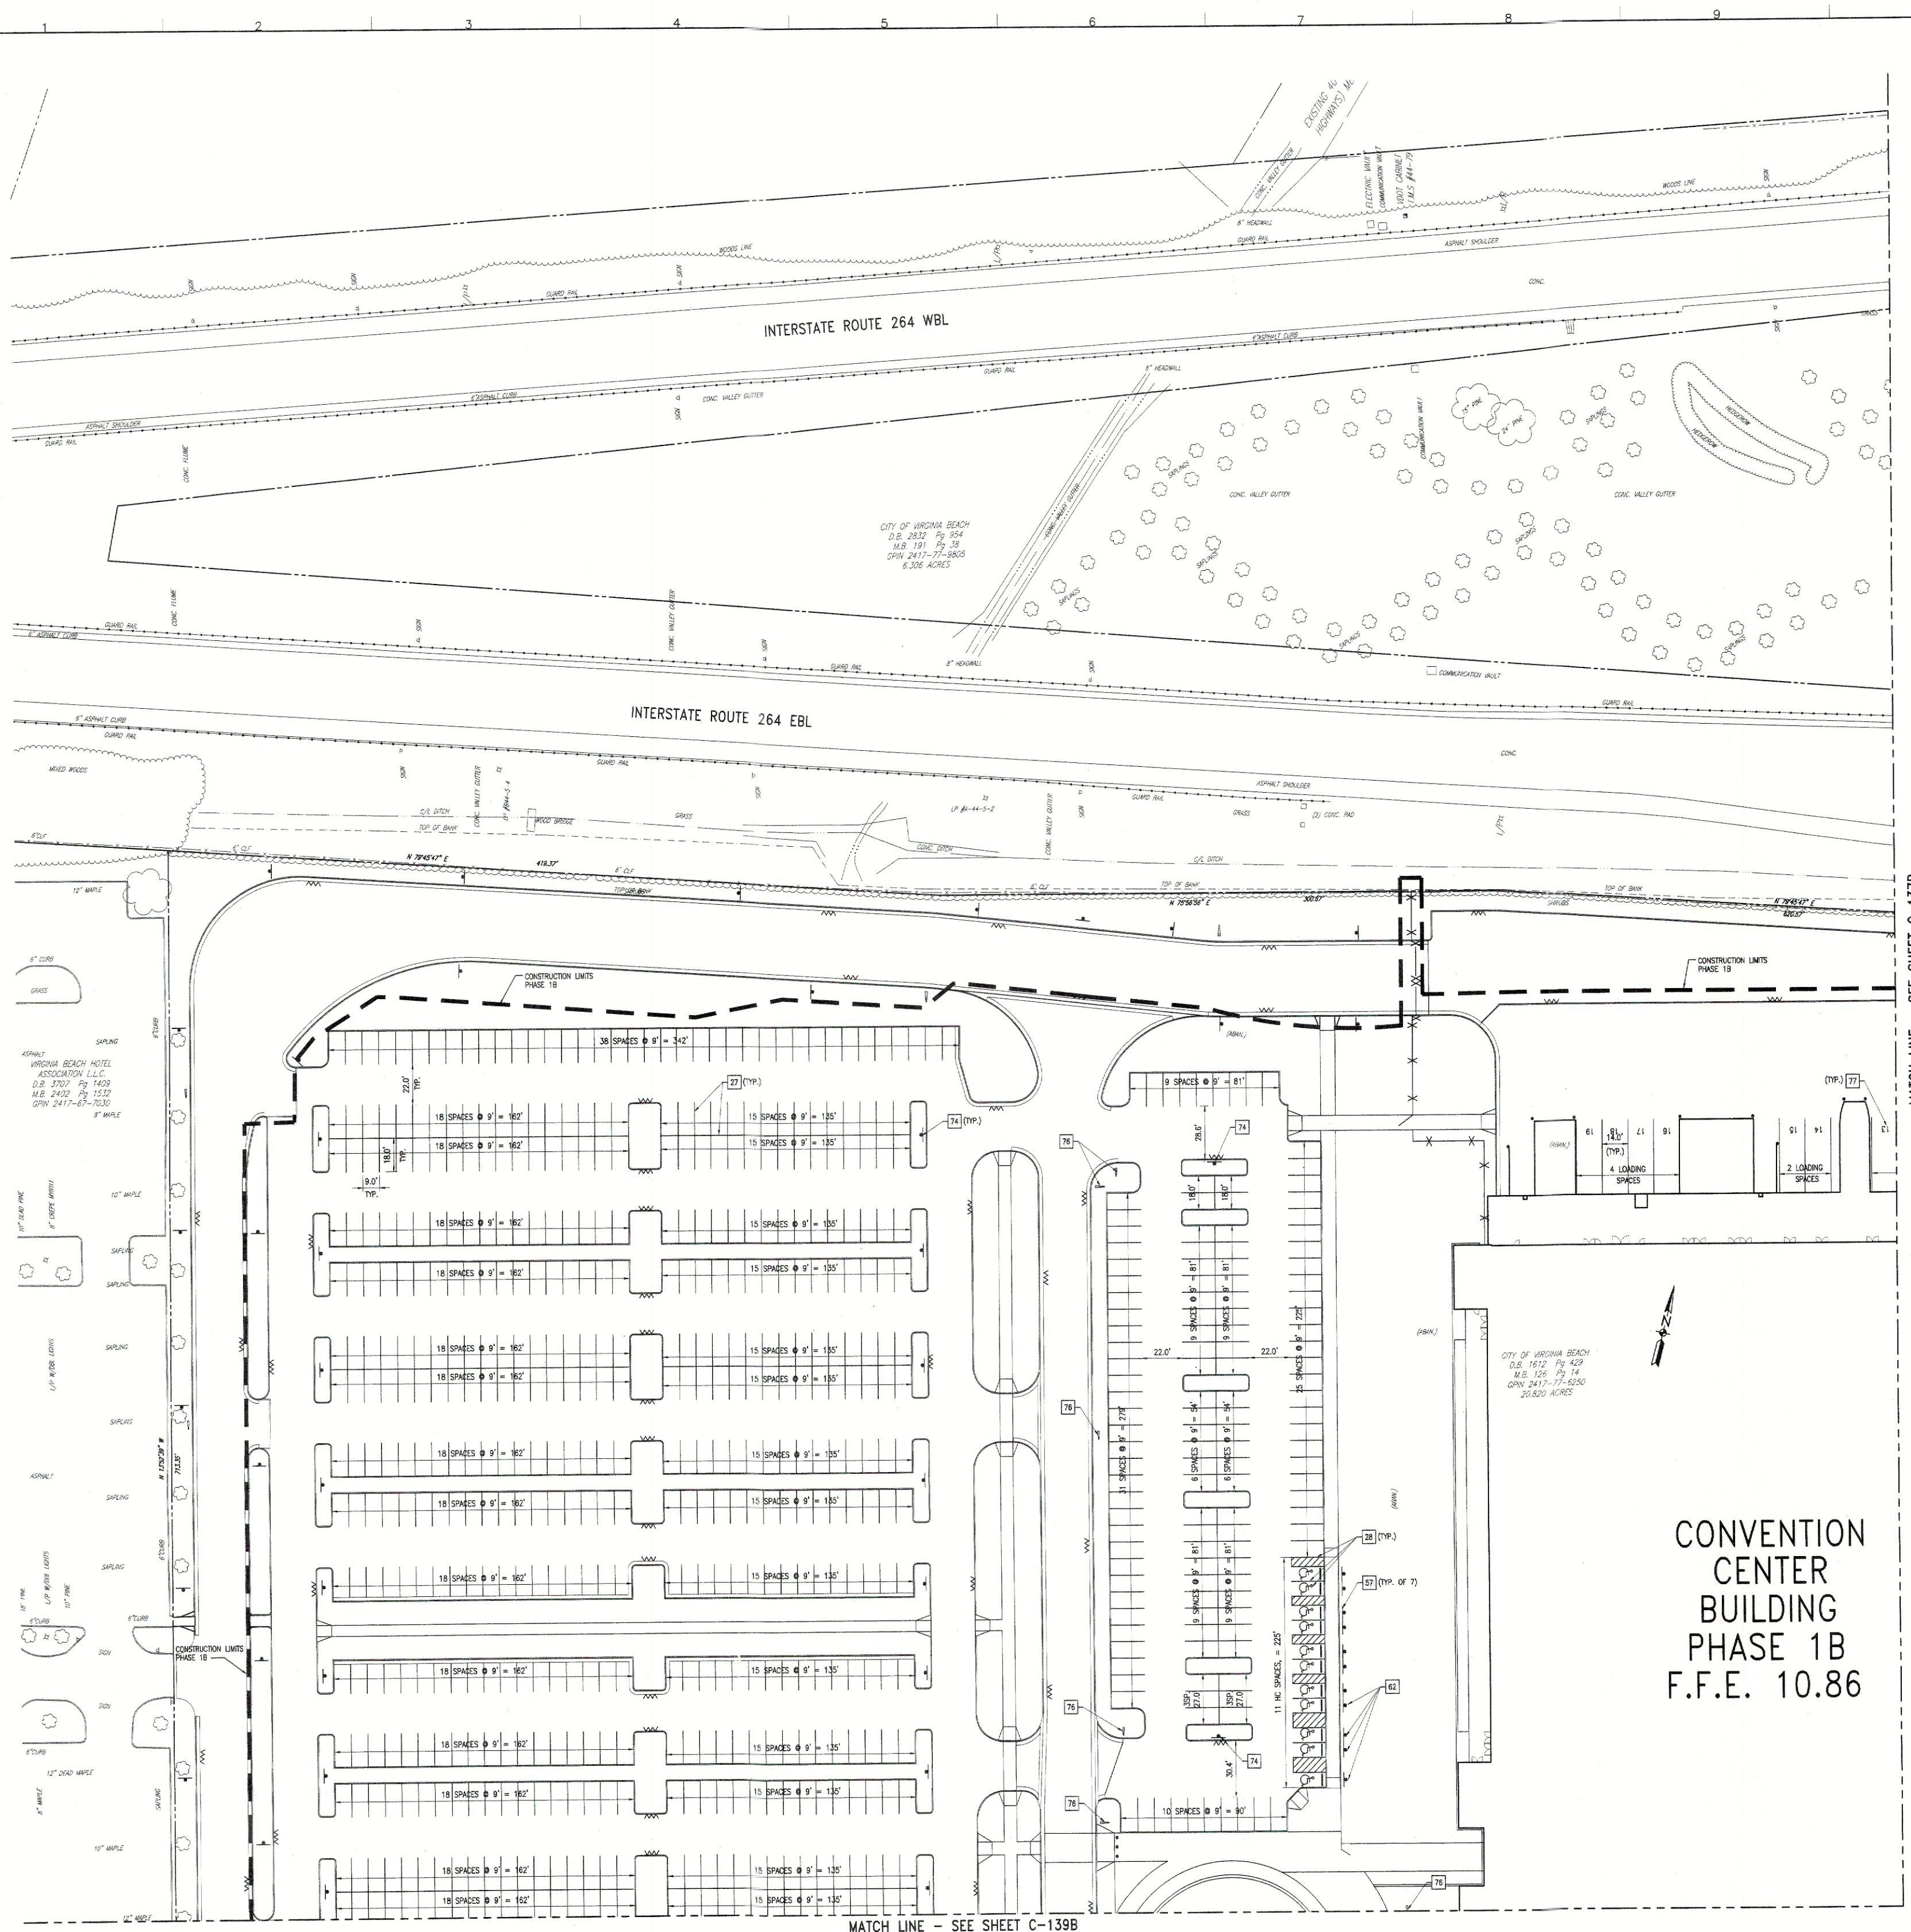

CONSTRUCTION NOTES

27	4" WHITE PAVEMENT MARKING
28	4" BLUE PAVEMENT MARKING
29	DOUBLE 4" YELLOW PAVEMENT MARKING
40	SITE VISIBILITY TRIANGLE
50	STOP SIGN
51	SPEED LIMIT 25 SIGN
52	DO NOT ENTER SIGN
53	LANE SHIFT SIGN (W-4) (R OR L)
54	ONE WAY SIGN (R OR L)
55	PEDESTRIAN CROSSING SIGN
56	NO LEFT TURN SIGN
57	HANDICAP PARKING SIGN ASSEMBLY
58	(NOT USED)
59	FIRE LANE SIGN
60	EXIT SIGN AND DIRECTIONAL ARROW (R OR L)
61	(NOT USED)
62	VAN ACCESSIBLE HANDICAP PARKING SIGN ASSEMBLY
63	CURB PAINTED HOT TRAFFIC YELLOW
64	6" WHITE PAVEMENT MARKING
65	24" WHITE PAVEMENT MARKING
66	PAVEMENT MARKING ARROW
67	PAVEMENT MESSAGE MARKING "ONLY"
68	REFLECTIVE PAVEMENT MARKERS
69	24" YELLOW PAVEMENT MARKING
70	(NOT USED)
71	(NOT USED)
72	(NOT USED)
73	12" WHITE PAVEMENT MARKING
74	NO PARKING SIGN
75	NO PARKING SIGN INSTALLED 1 FOOT BEHIND BOLLARD
76	REFER TO GRAPHIC SIGN PLAN, SCHEDULES AND DETAILS
77	6" WHITE PAVEMENT MARKING, DESIGNATED NUMBER, 4 FOOT HIGH

Virginia Beach Convention Center
City of Virginia Beach
Department of Public Works
Municipal Center - Building 2
2405 Courthouse Drive,
Virginia Beach 23456-9031

Architect / Engineer:
SOM
Skidmore, Owings & Merrill LLP
224 South Michigan Avenue
Suite 1000
Chicago, Illinois 60604

Consultant Engineering:
CLARK+NEXSEN
Architecture & Engineering
6160 Kempsville Circle
Suite 200A
Norfolk, Virginia 23502

Consultant:

Seal & Signature

08 7 NOV 03 BULLETIN NO. 1 - ISSUED FOR FINAL CONSTRUCTION
07 12 AUG 03 ADDENDUM NO. 14 - ISSUE FOR CONSTRUCTION AND OSC PERMIT
06 30 MAY 03 ADD. NO. 10 - ISSUED FOR FINAL GMP
05 15 MAY 03 ISSUED FOR BUILDING PERMIT
04 12 MAY 03 ADDENDUM NO. 8 - ISSUED FOR GMP
03 18 APR 03 ISSUED FOR VIRGINIA BEACH OSC PERMIT
02 28 MAR 03 ADDENDUM NO. 6 - ISSUED FOR REVISION TO SITE, UTILITY, DRAINAGE, LAYOUT AND UTILITIES PLAN
01 26 MAR 03 ISSUED FOR VA BEACH OSC PERMIT

Project No: 201199
Date: Mar 26, 03
Scale: 1"=30'

Sheet No:
C-136B
© Skidmore, Owings & Merrill LLP 2004

CONVENTION CENTER BUILDING PHASE 1B
F.F.E. 10.86

GRAPHIC SCALE
1"=30' 0 30' 60' 120'

MATCH LINE - SEE SHEET C-139B

MATCH LINE - SEE SHEET C-137B